



S:\4301 - AVRA Maintenance Bid\DWGS\S4301.DWG 21 September 2022 4:16 PM

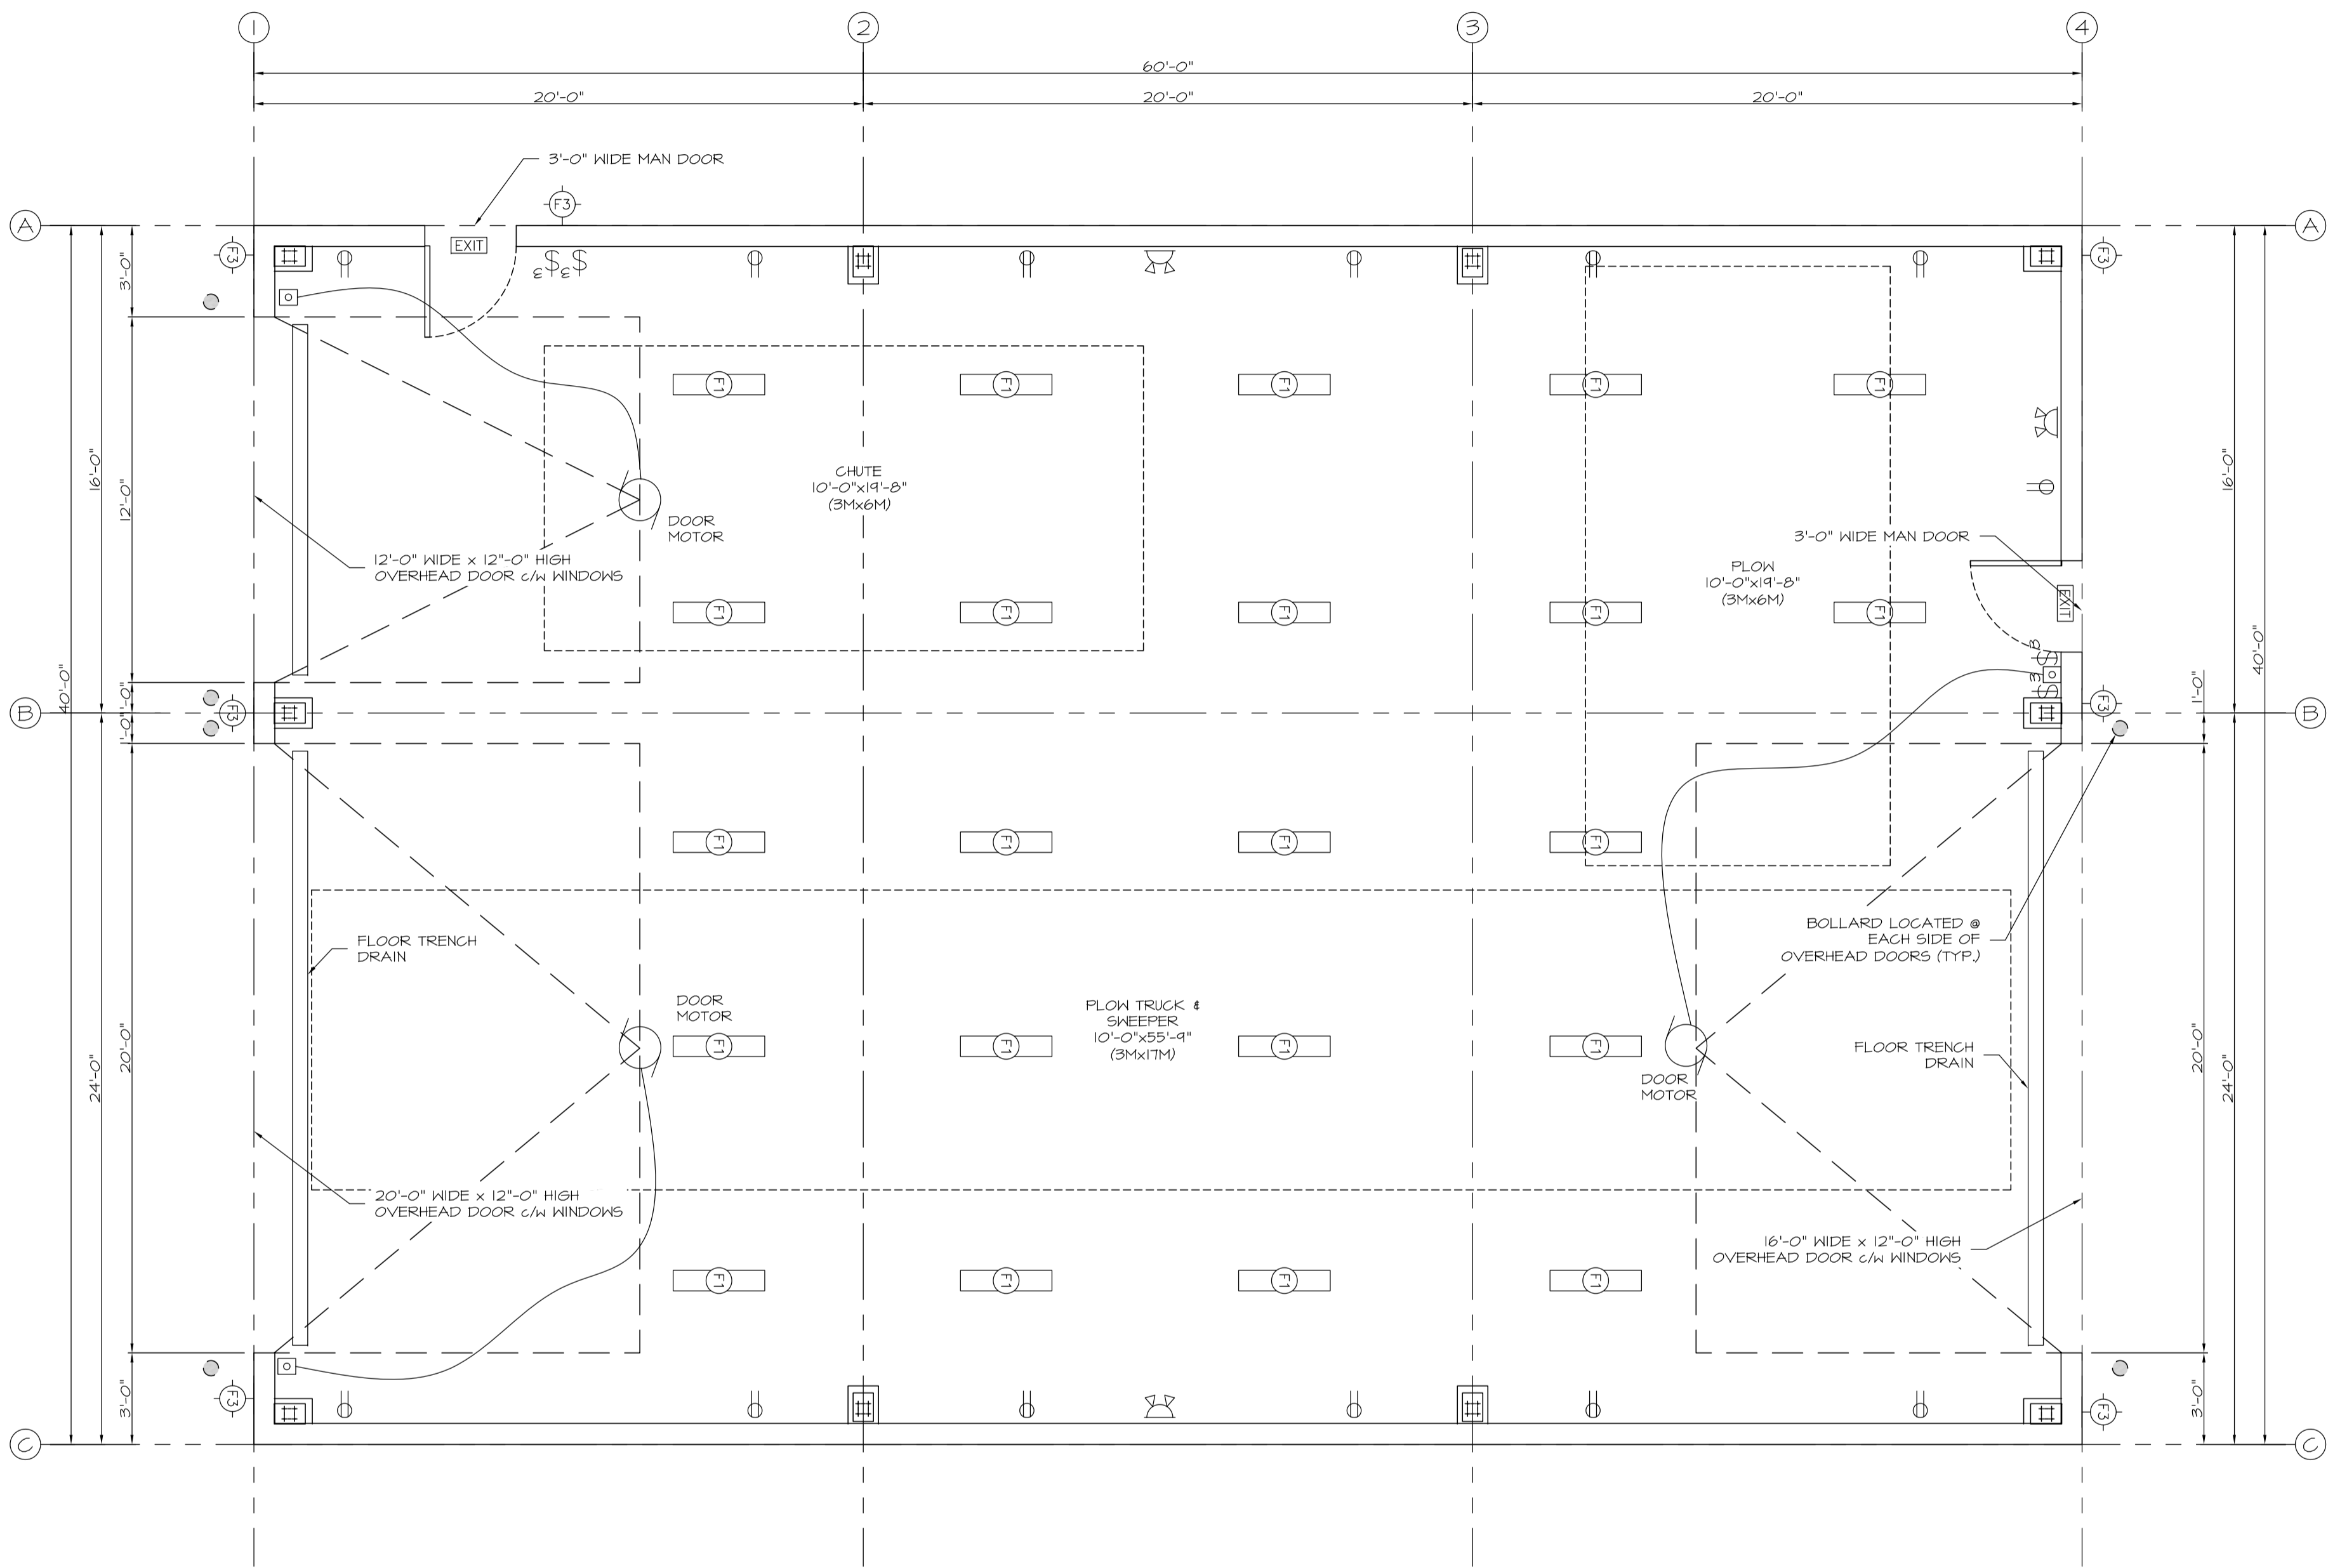

PROPOSED FLOOR PLAN
SCALE: 1/4" = 1'-0"

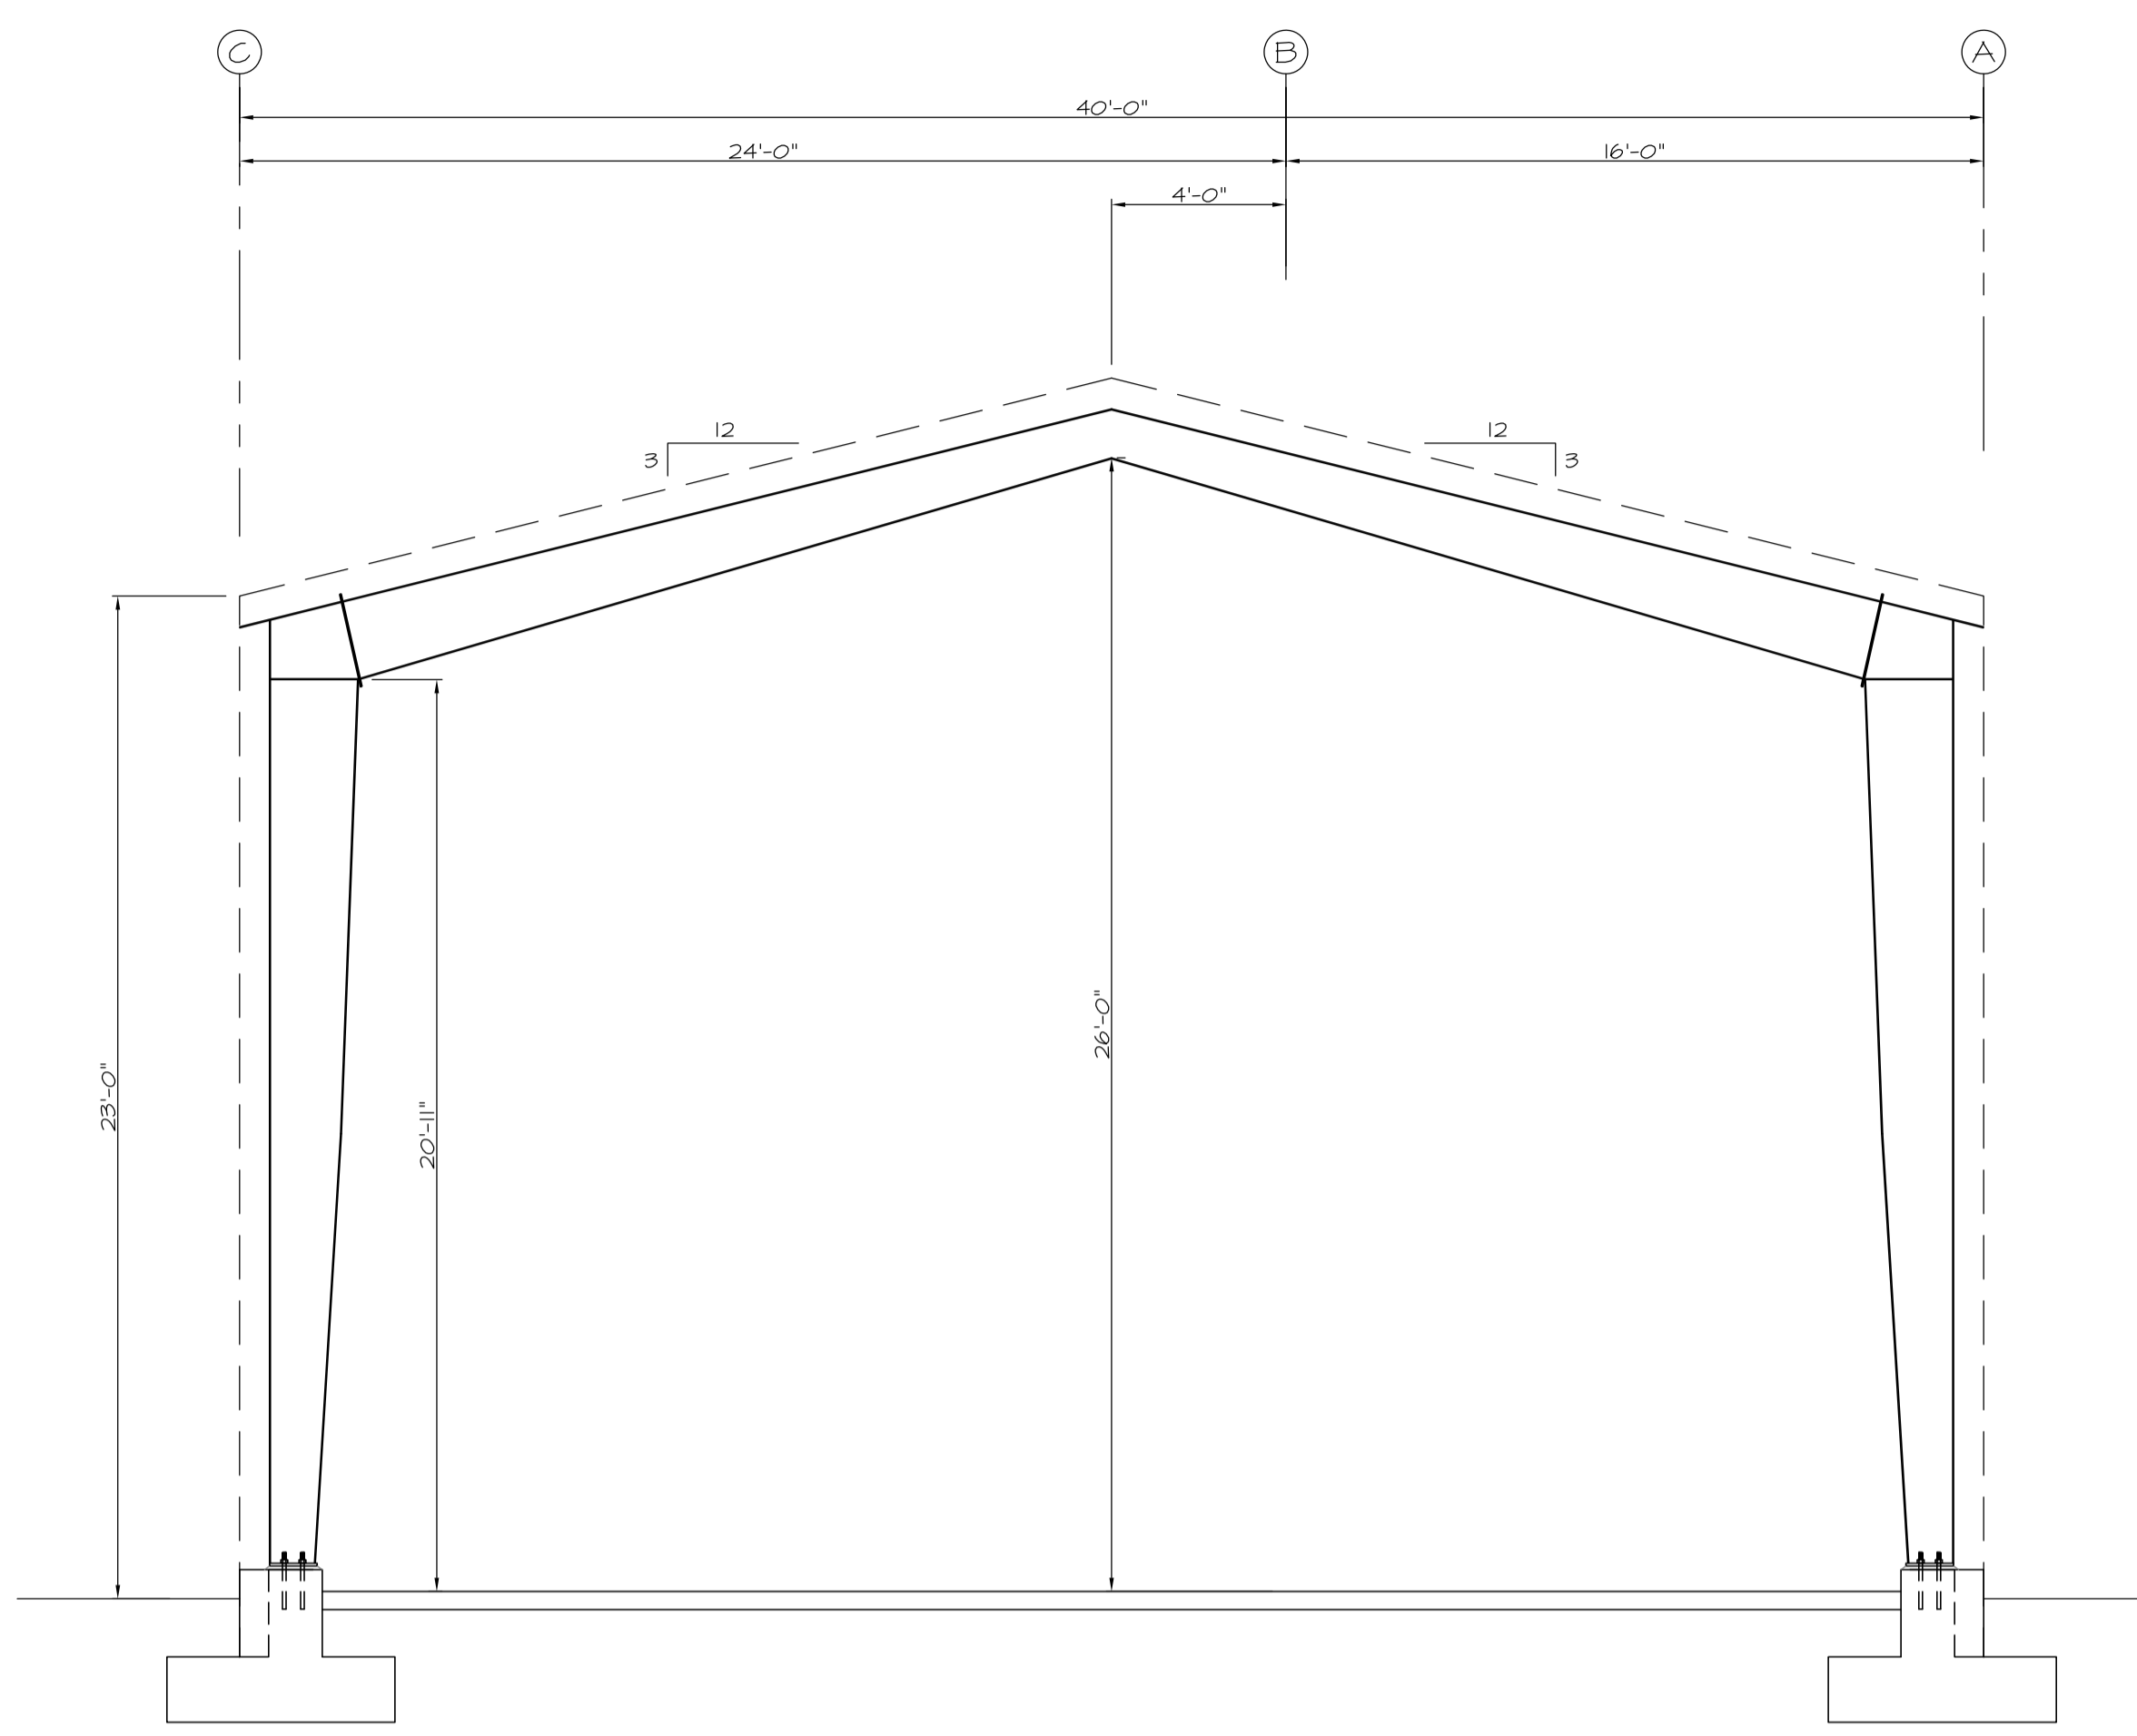

TYPICAL SECTION
SCALE: 1/4" = 1'-0"

SYMBOL LEGEND

SYMBOL	MOUNTING	DESCRIPTION
	CEILING/WALL	1' x 4' FLUORESCENT, SURFACE
	WALL	INCANDESCENT/HID/FLUORESCENT, SURFACE
	300mm (12") A.F.F.	DUPLEX RECEPTACLE, 1 GANG
	1300mm (52") A.F.F.	3-WAY, 1 GANG SWITCH
	-	MOTOR CONNECTION
	1300mm (52") A.F.F.	PUSH BUTTON
	2400mm (96") A.F.F.	REMOTE EMERGENCY LIGHT, DOUBLE HEADS, WALL MOUNTED c/w INTEGRAL BATTERY


LUMINAIRE SCHEDULE

TYPE	MANUFACTURER	CATALOG No.	MOUNTING	DESCRIPTION	LAMP		REMARKS
					TYPE	QTY	
F1	GVA LIGHTING	FAD232PC120	SURFACE, CEILING	4' @ASKETED	32W T8	2	
F2	RWD	E8232-WL-B5	SURFACE, WALL	EXTERIOR WALL PACK	42W PL	1	

- BUILDING NOTES:**
- PASSIVE ELECTRICAL HEATER TO BE PROVIDED TO PROVIDE MINIMUM LOW HEAT STORAGE.
 - INTERIOR OVERHEAD LIGHTINGS AND EXTERIOR LIGHTS OVER VEHICLE AND MAN DOORS.
 - ELECTRICAL RECEPTACLES TO BE PROVIDED BOTH INSIDE AND OUTSIDE OF BUILDING.
 - HOSE BIB TO BE PROVIDED ON EXTERIOR OF BUILDING.

THIS PLAN AND DESIGN ARE, AND AT ALL TIMES REMAIN THE EXCLUSIVE PROPERTY OF MCGILL & ASSOCIATES ENGINEERING LTD. AND CANNOT BE USED OR REPRODUCED WITHOUT WRITTEN CONSENT. THIS PLAN IS PREPARED FOR THE SOLE USE OF OUR CLIENT AND NO REPRESENTATION OF ANY KIND IS MADE TO OTHER PARTIES WITH WHICH MCGILL & ASSOCIATES ENGINEERING LTD. HAS NOT ENTERED INTO A CONTRACT. WRITTEN DIMENSIONS SHALL HAVE PRECEDENCE OVER SCALED DIMENSIONS. CONTRACTORS SHALL VERIFY AND BE RESPONSIBLE FOR ALL DIMENSIONS AND CONDITIONS ON THE JOB AND THIS OFFICE SHALL BE INFORMED OF ANY VARIATIONS FROM THE DIMENSIONS AND CONDITIONS SHOWN ON THE DRAWINGS.

DESIGN:	BAW				
DRAWN:	CJM				
CHECKED:	BAW				
APPROVED:					
DATE:	SEPT. 2022				
SCALE:	AS NOTED				
A	ISSUED FOR TENDER	2022/11/10	CJM	BAW	FIELD BOOK No.
No.	REVISION DESCRIPTION	DATE	BY	APP'D	DWG File Name

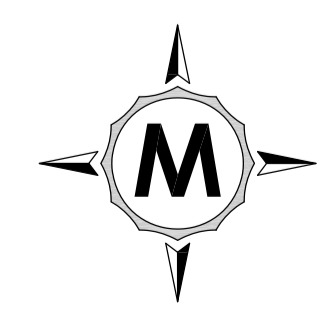


McGILL & ASSOCIATES ENGINEERING LTD.

PERMIT TO PRACTICE No. 1002564
4610 ELIZABETH STREET
PORT ALBERNI, B.C., V9Y 6L7
telephone: (250) 724-3400 fax: (250) 724-4400
email: office@mcgilleng.com

ALBERNI CLAYOQUOT REGIONAL DISTRICT
CBS8 - ALBERNI, MAINTENANCE BUILDING

FLOOR PLAN

SHEET No.	A01
1 OF 2	REV. A
DRAWING No.	4301 - A01

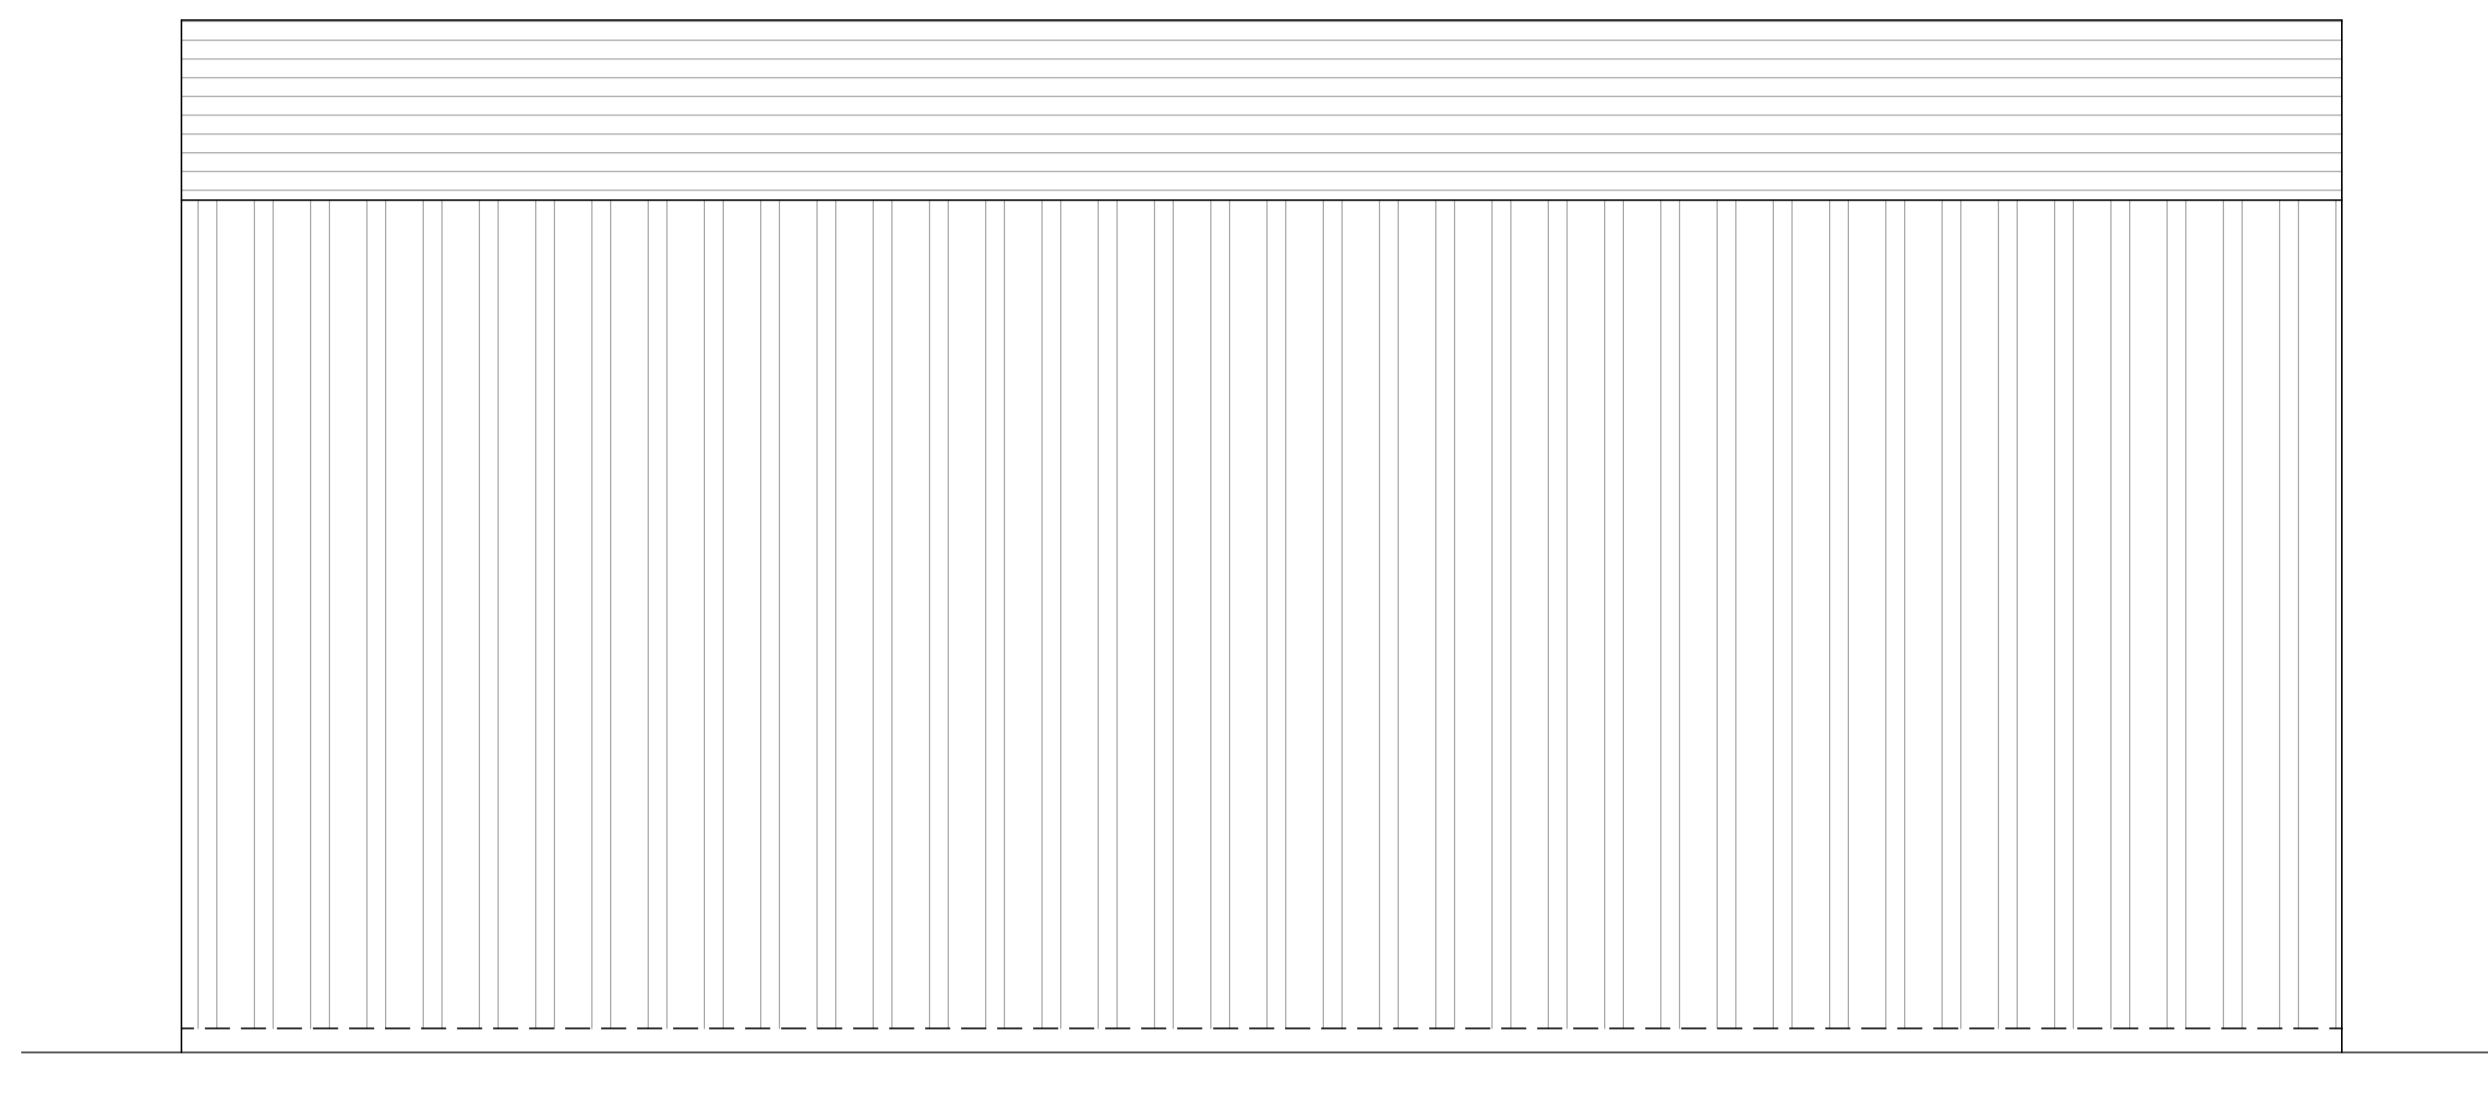


SOUTH ELEVATION
SCALE: 3/16" = 1'-0"

HIGH ROOF
28'-8"

EAVE HEIGHT
23'-0"

FIN. FL. ELEV.
0'-0"

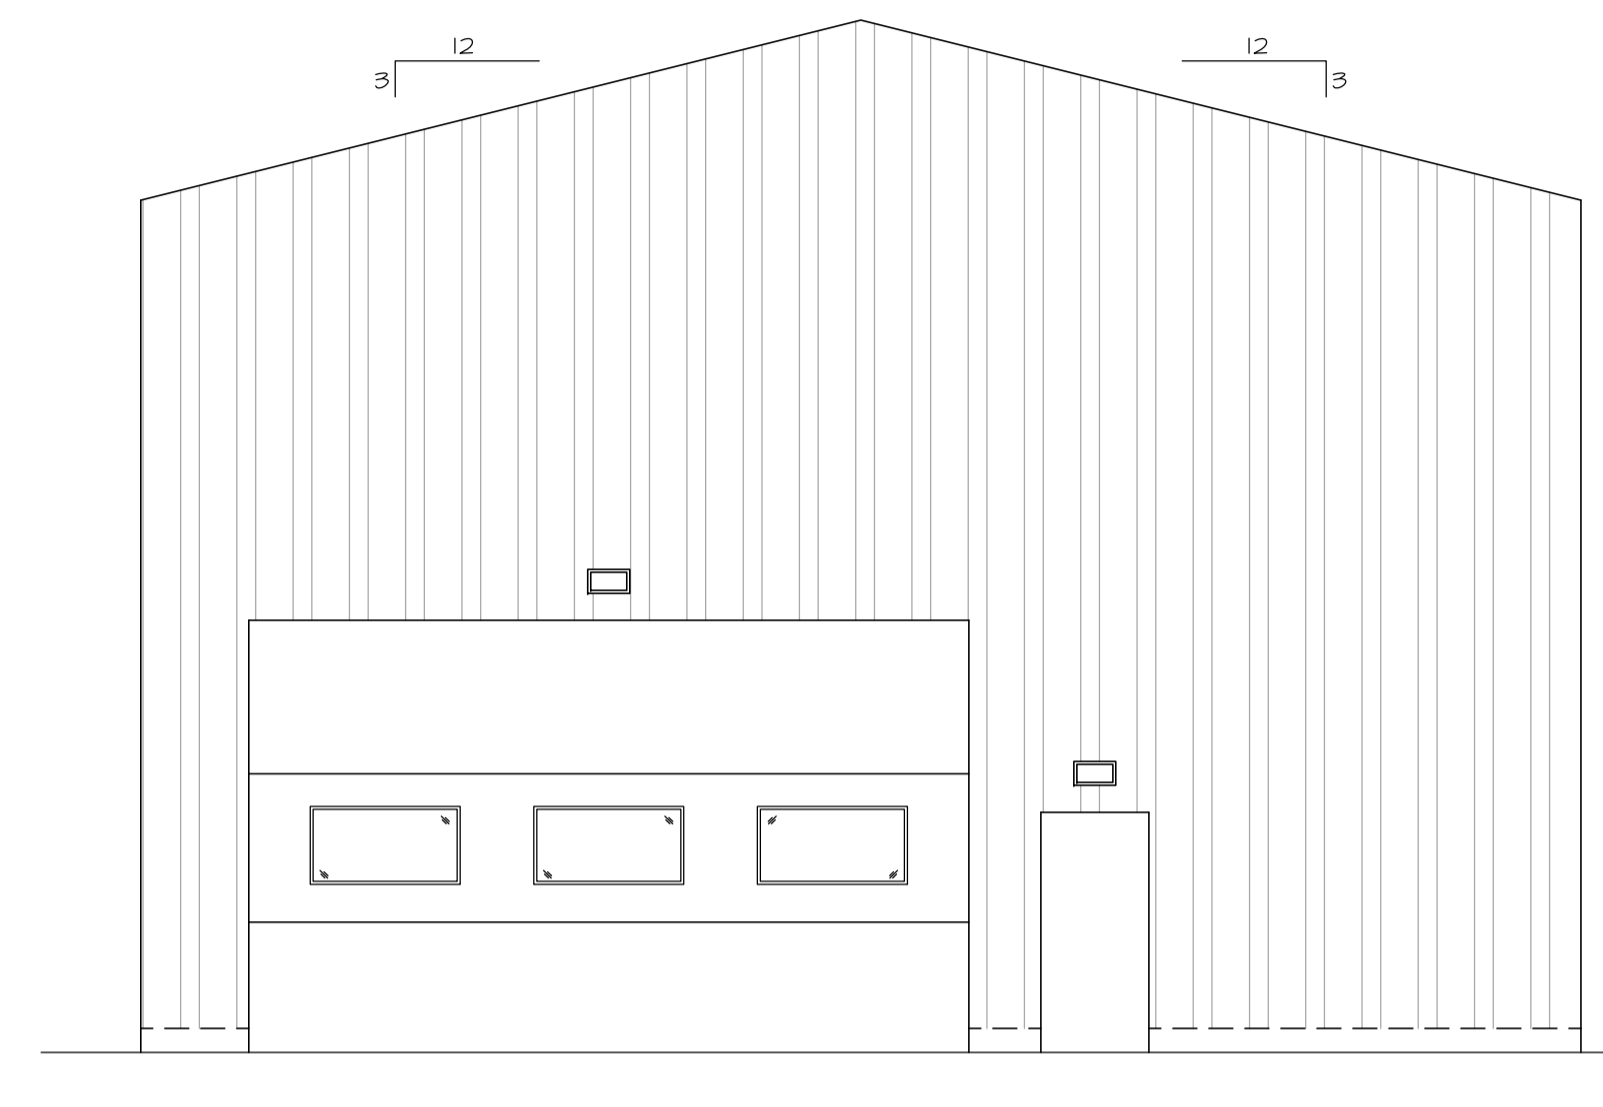


EAST ELEVATION
SCALE: 3/16" = 1'-0"

HIGH ROOF
28'-8"

EAVE HEIGHT
23'-0"

FIN. FL. ELEV.
0'-0"

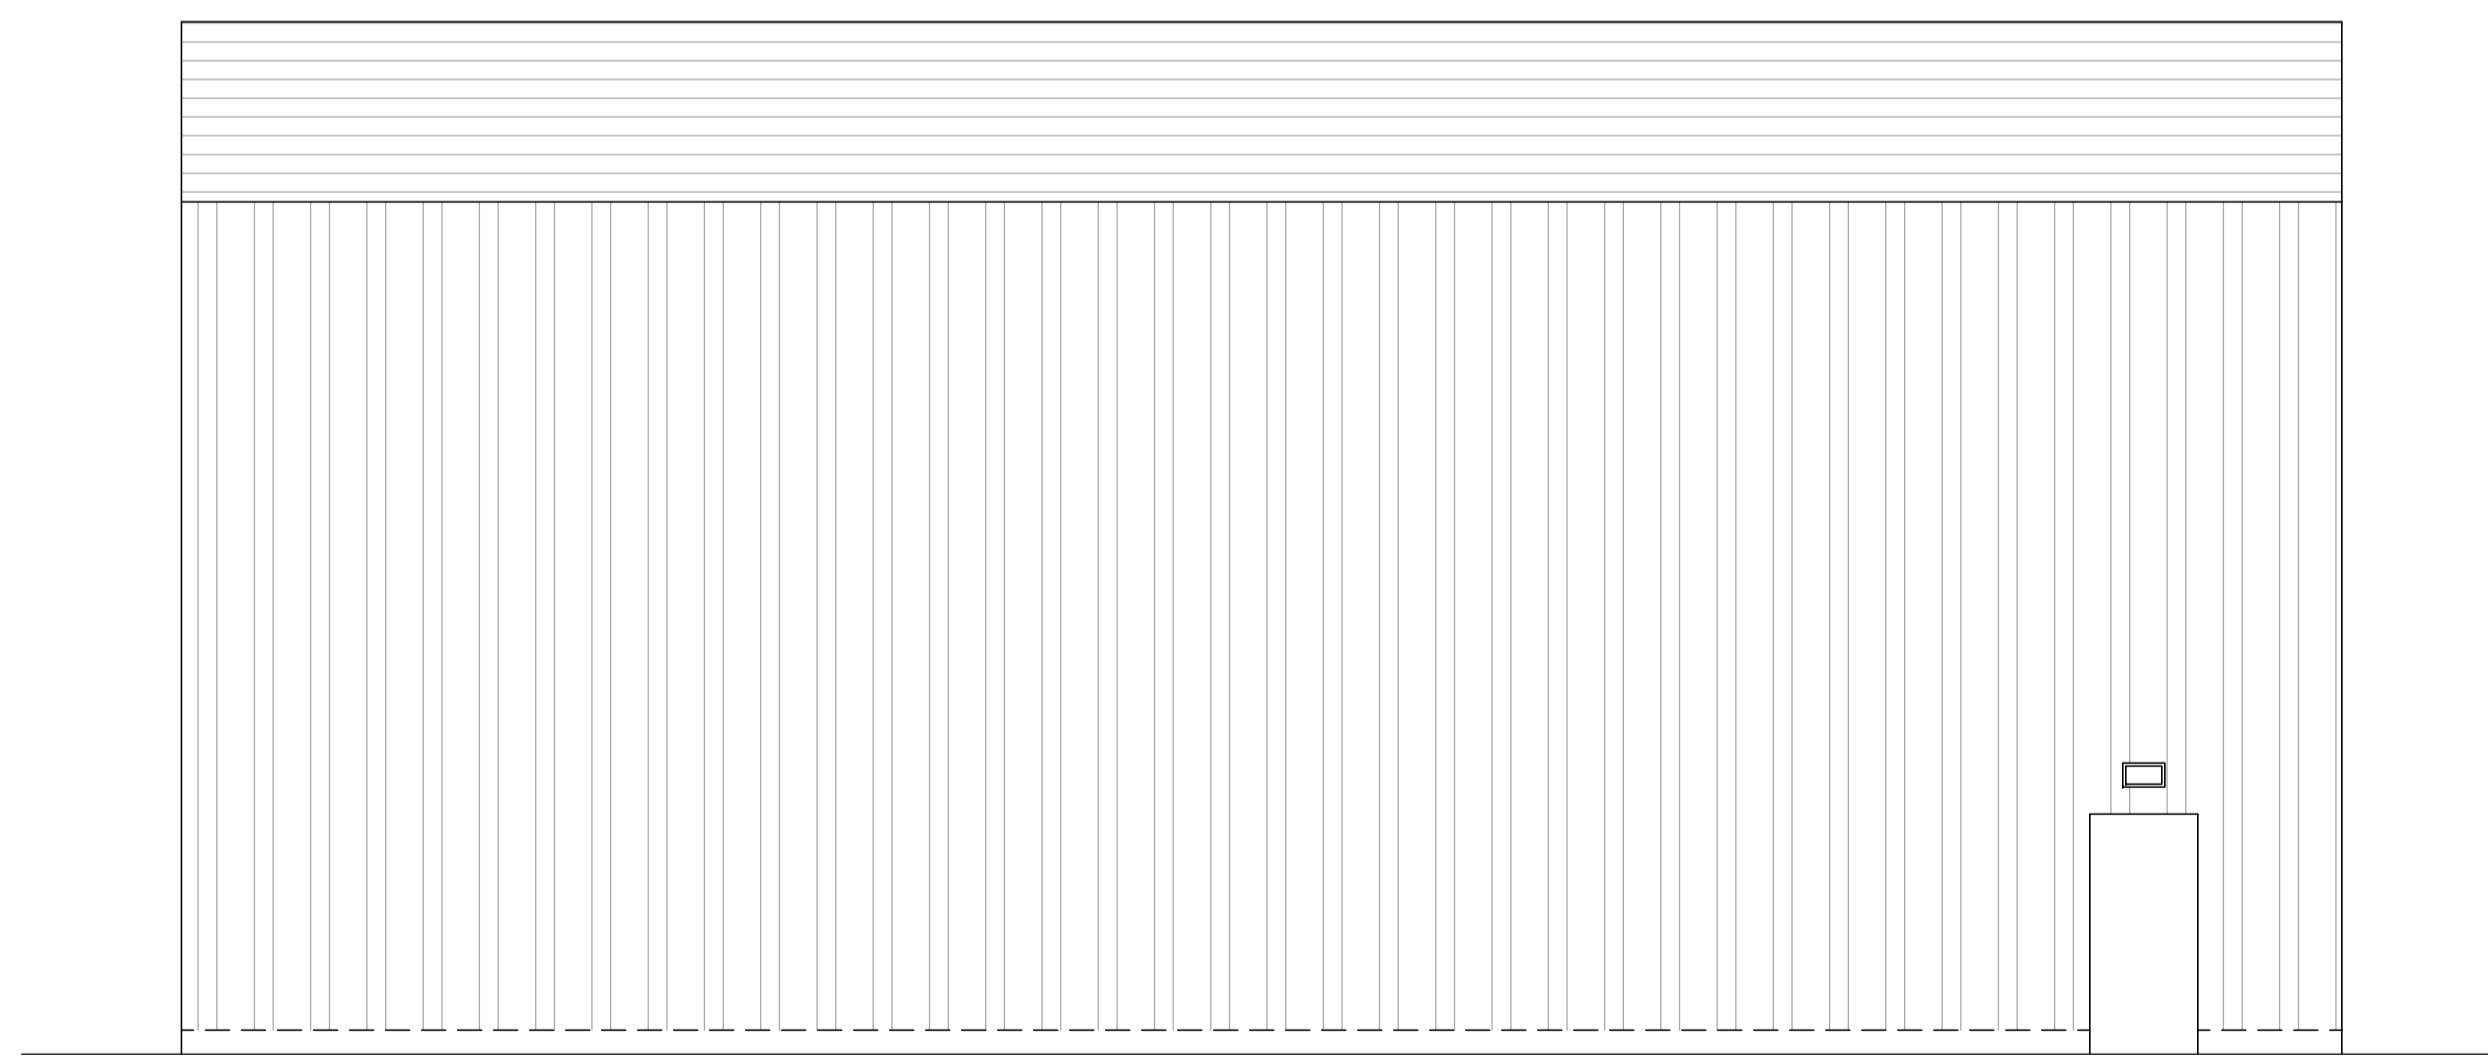


NORTH ELEVATION
SCALE: 3/16" = 1'-0"

HIGH ROOF
28'-8"

EAVE HEIGHT
23'-0"

FIN. FL. ELEV.
0'-0"

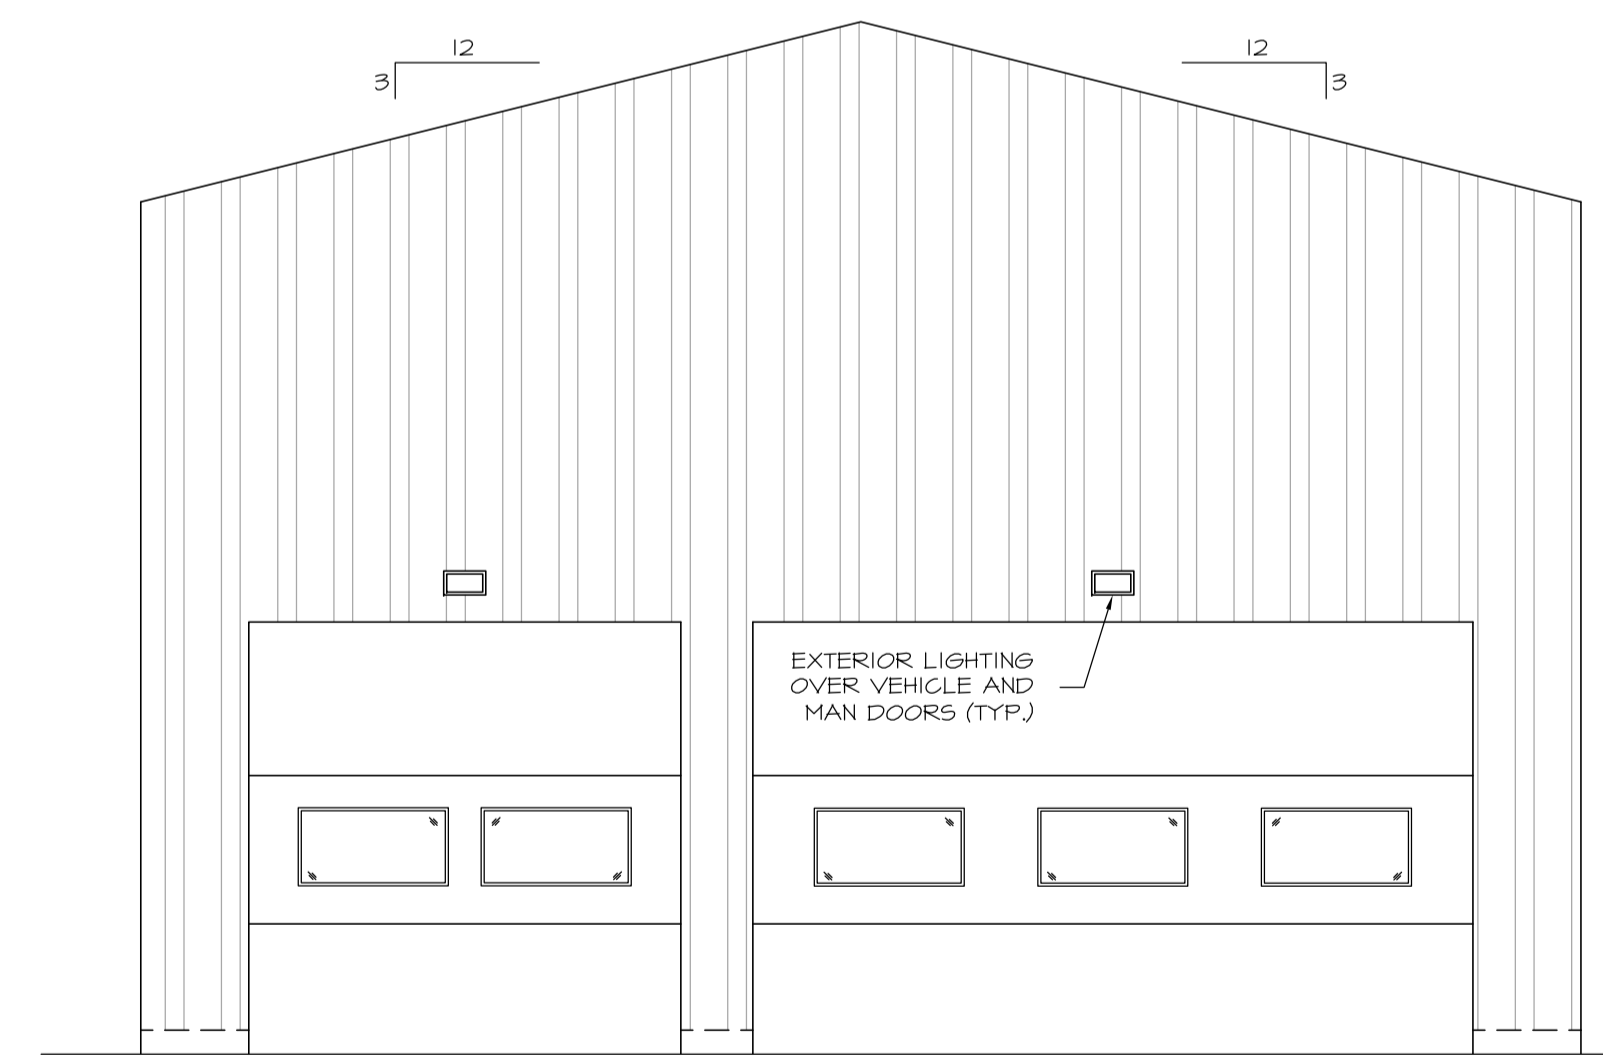

WEST ELEVATION
SCALE: 3/16" = 1'-0"


HIGH ROOF
28'-8"

EAVE HEIGHT
23'-0"

FIN. FL. ELEV.
0'-0"

THIS PLAN AND DESIGN ARE, AND AT ALL TIMES REMAIN THE EXCLUSIVE PROPERTY OF MCGILL & ASSOCIATES ENGINEERING LTD. AND CANNOT BE USED OR REPRODUCED WITHOUT WRITTEN CONSENT. THIS PLAN IS PREPARED FOR THE SOLE USE OF OUR CLIENT AND NO REPRESENTATION OF ANY KIND IS MADE TO OTHER PARTIES WITH WHICH MCGILL & ASSOCIATES ENGINEERING LTD. HAS NOT ENTERED INTO A CONTRACT. WRITTEN DIMENSIONS SHALL HAVE PRECEDENCE OVER SCALED DIMENSIONS. CONTRACTORS SHALL VERIFY AND BE RESPONSIBLE FOR ALL DIMENSIONS AND CONDITIONS ON THE JOB AND THIS OFFICE SHALL BE INFORMED OF ANY VARIATIONS FROM THE DIMENSIONS AND CONDITIONS SHOWN ON THE DRAWINGS.

No.	REVISION DESCRIPTION	DATE	BY	APP'D	DESIGN	DATE	SCALE	FIELD BOOK No.	DWG File Name	SEAL
A	ISSUED FOR TENDER	2022/11/10	CJM	BAW	DESIGN: BAW	SEPT. 2022	AS NOTED		S4301.DWG	
					DRAWN: CJM					
					CHECKED: BAW					
					APPROVED:					

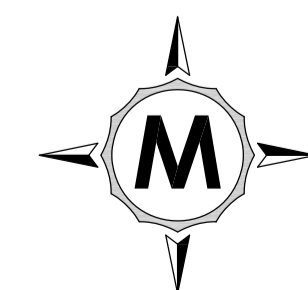

**McGILL & ASSOCIATES
ENGINEERING LTD.**

PERMIT TO PRACTICE No. 1002564
4610 ELIZABETH STREET
PORT ALBERNI, B.C., V9Y 6L7
telephone: (250) 724-3400 fax: (250) 724-4400
email: office@mcgilleng.com

ALBERNI CLAYOQUOT REGIONAL DISTRICT
CBS8 - ALBERNI, MAINTENANCE BUILDING

ELEVATION VIEWS

SHEET No.


A02

2 OF 2 REV. A

DRAWING No.

4301 - A02

S:\4301 - AVRA Maintenance Bid\DWGS\S4301.DWG 21 September 2022 4:16 PM

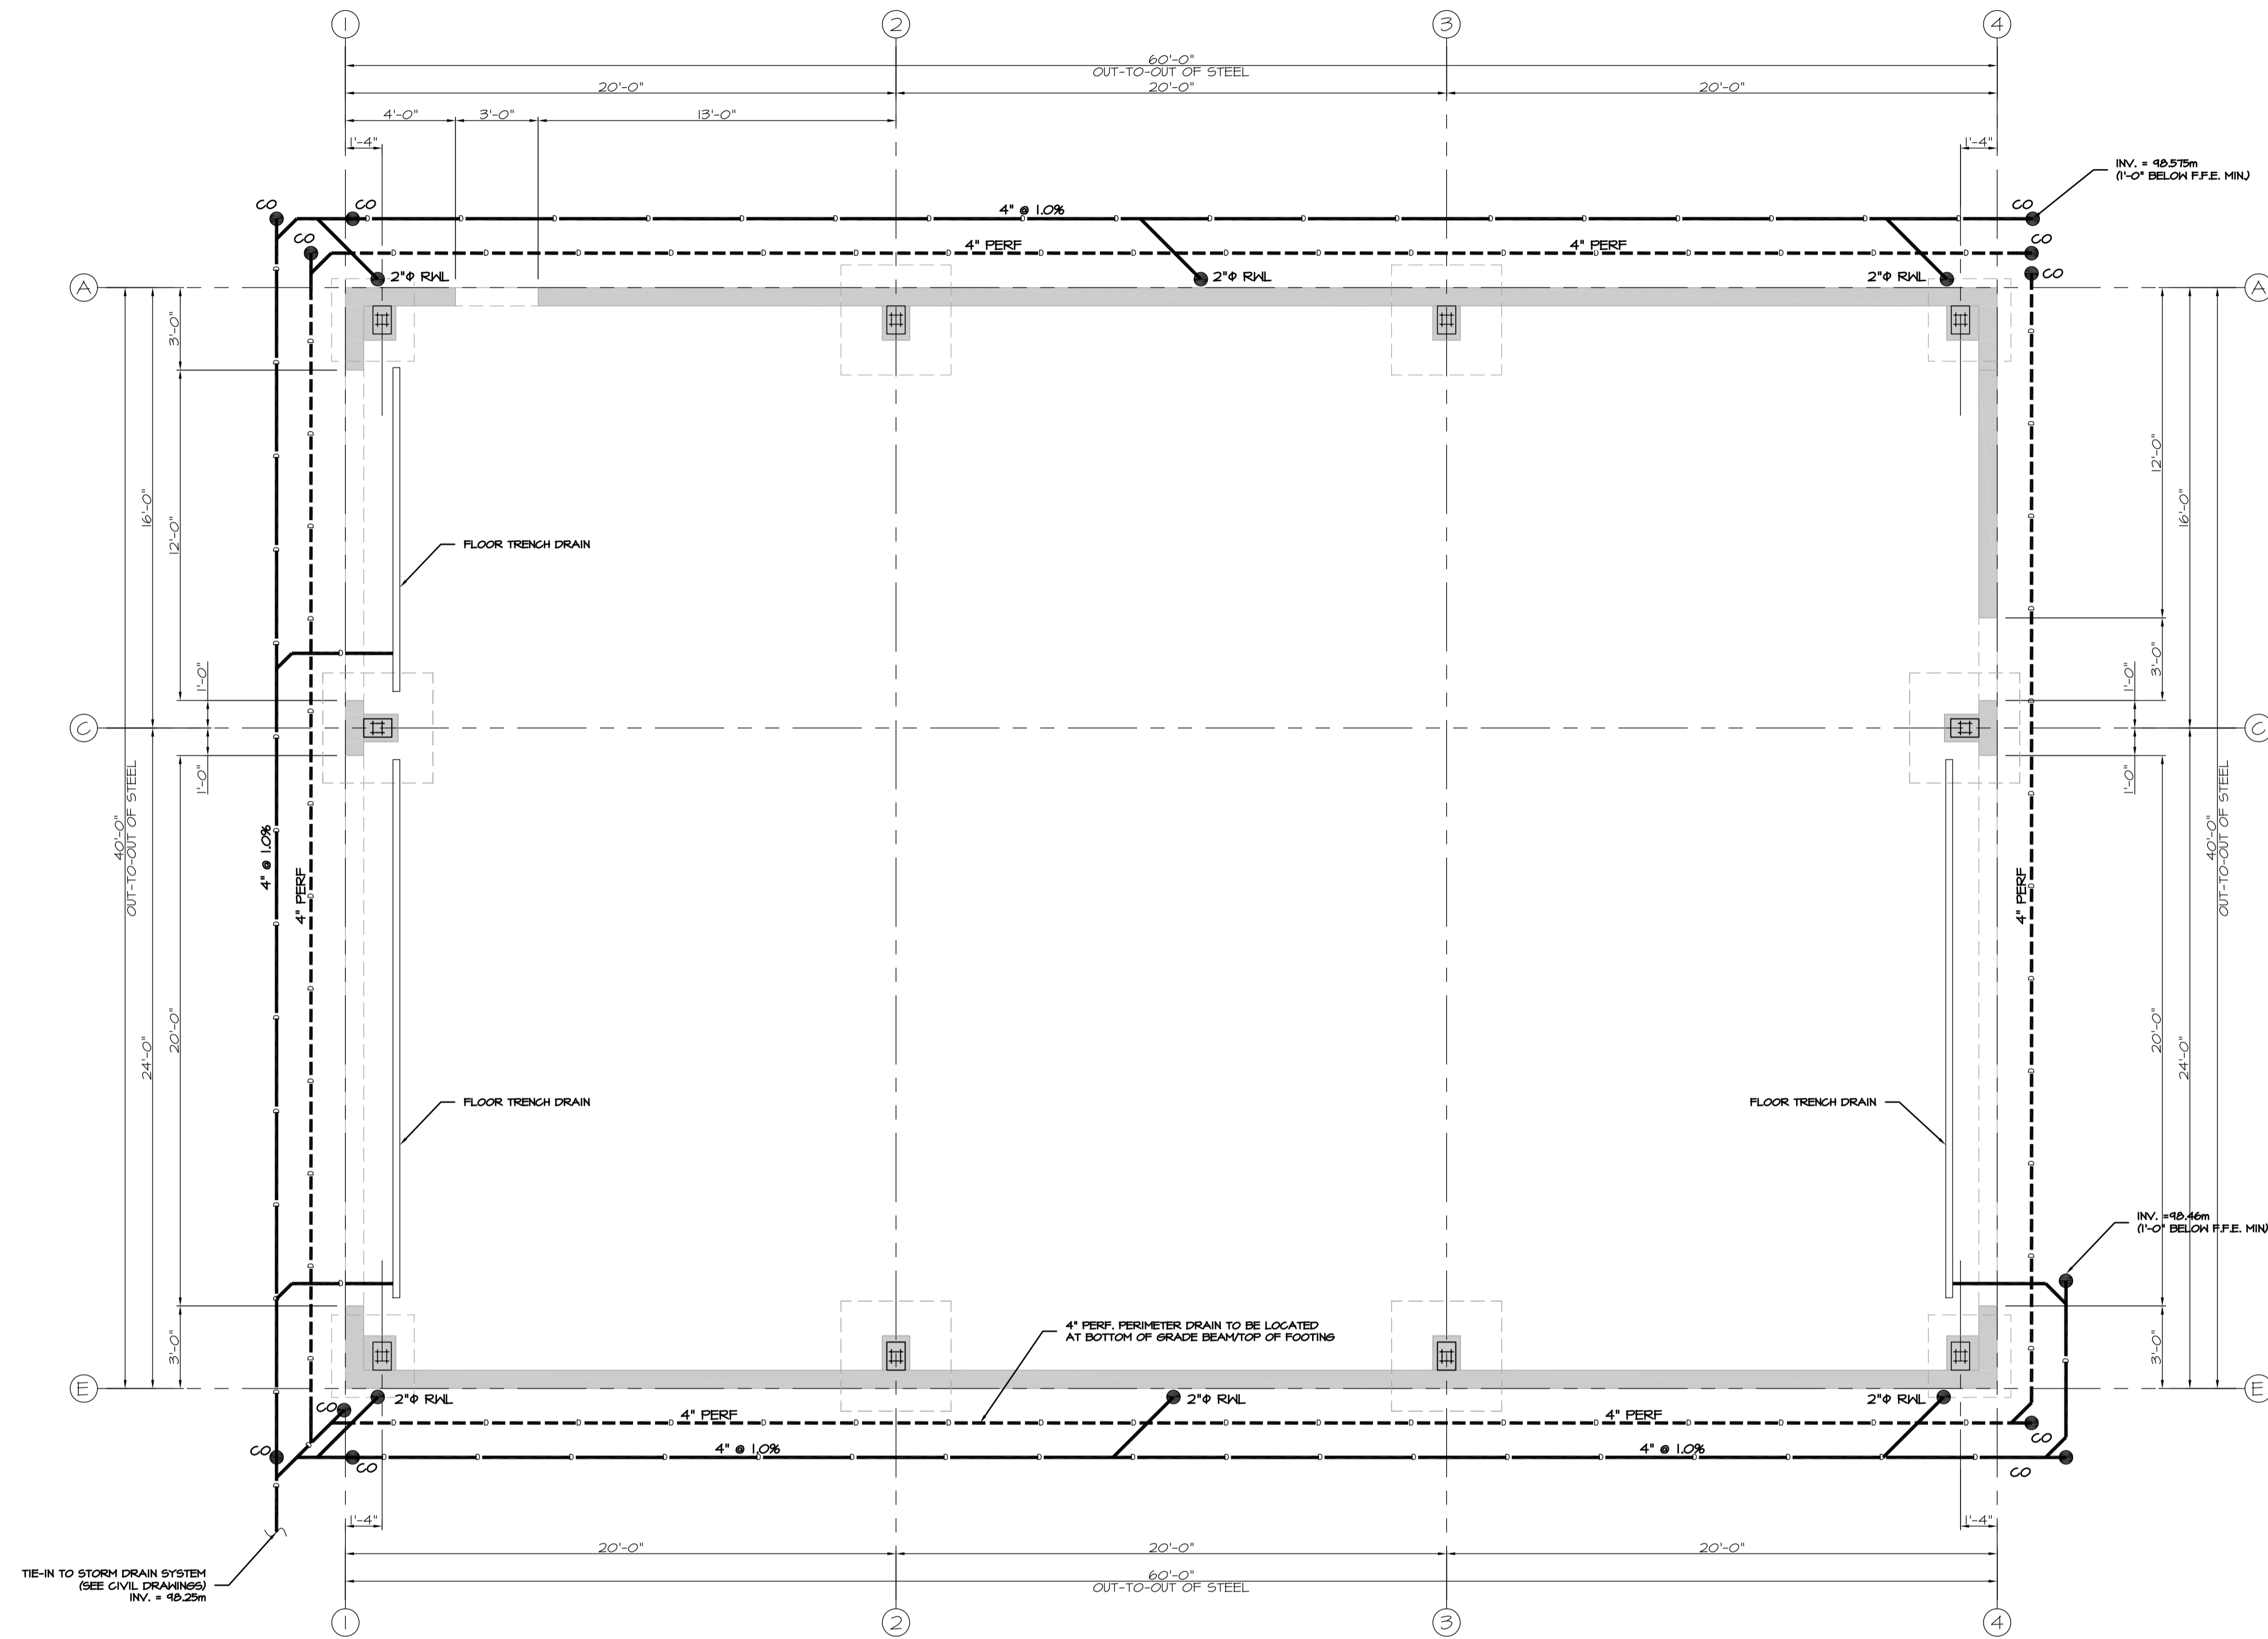

THIS PLAN AND DESIGN ARE, AND AT ALL TIMES REMAIN THE EXCLUSIVE PROPERTY OF MCGILL & ASSOCIATES ENGINEERING LTD. AND CANNOT BE USED OR REPRODUCED WITHOUT WRITTEN CONSENT. THIS PLAN IS PREPARED FOR THE SOLE USE OF OUR CLIENT AND NO REPRESENTATION OF ANY KIND IS MADE TO OTHER PARTIES WITH WHICH MCGILL & ASSOCIATES ENGINEERING LTD. HAS NOT ENTERED INTO A CONTRACT. WRITTEN DIMENSIONS SHALL HAVE PRECEDENCE OVER SCALED DIMENSIONS. CONTRACTORS SHALL VERIFY AND BE RESPONSIBLE FOR ALL DIMENSIONS AND CONDITIONS ON THE JOB AND THIS OFFICE SHALL BE INFORMED OF ANY VARIATIONS FROM THE DIMENSIONS AND CONDITIONS SHOWN ON THE DRAWINGS.

No.	REVISION DESCRIPTION	DATE	BY	APP'D
A	ISSUED FOR TENDER	2022/11/10	CJM	BAW

DESIGN:	BAW
DRAWN:	CJM
CHECKED:	BAW
APPROVED:	
DATE:	SEPT. 2022
SCALE:	AS NOTED
FIELD BOOK No.	
DWG File Name	S4301.DWG



**McGILL & ASSOCIATES
ENGINEERING LTD.**

PERMIT TO PRACTICE No. 1002564
4610 ELIZABETH STREET
PORT ALBERNI, B.C., V9Y 6L7
telephone: (250) 724-3400 fax: (250) 724-4400
email: office@mcslleng.com

ALBERNI CLAYOQUOT REGIONAL DISTRICT
CBS8 - ALBERNI, MAINTENANCE BUILDING
PLUMBING PLAN

SHEET No.	M01
1 OF 1	REV. A
DRAWING No.	4301 - M01